


NORTH

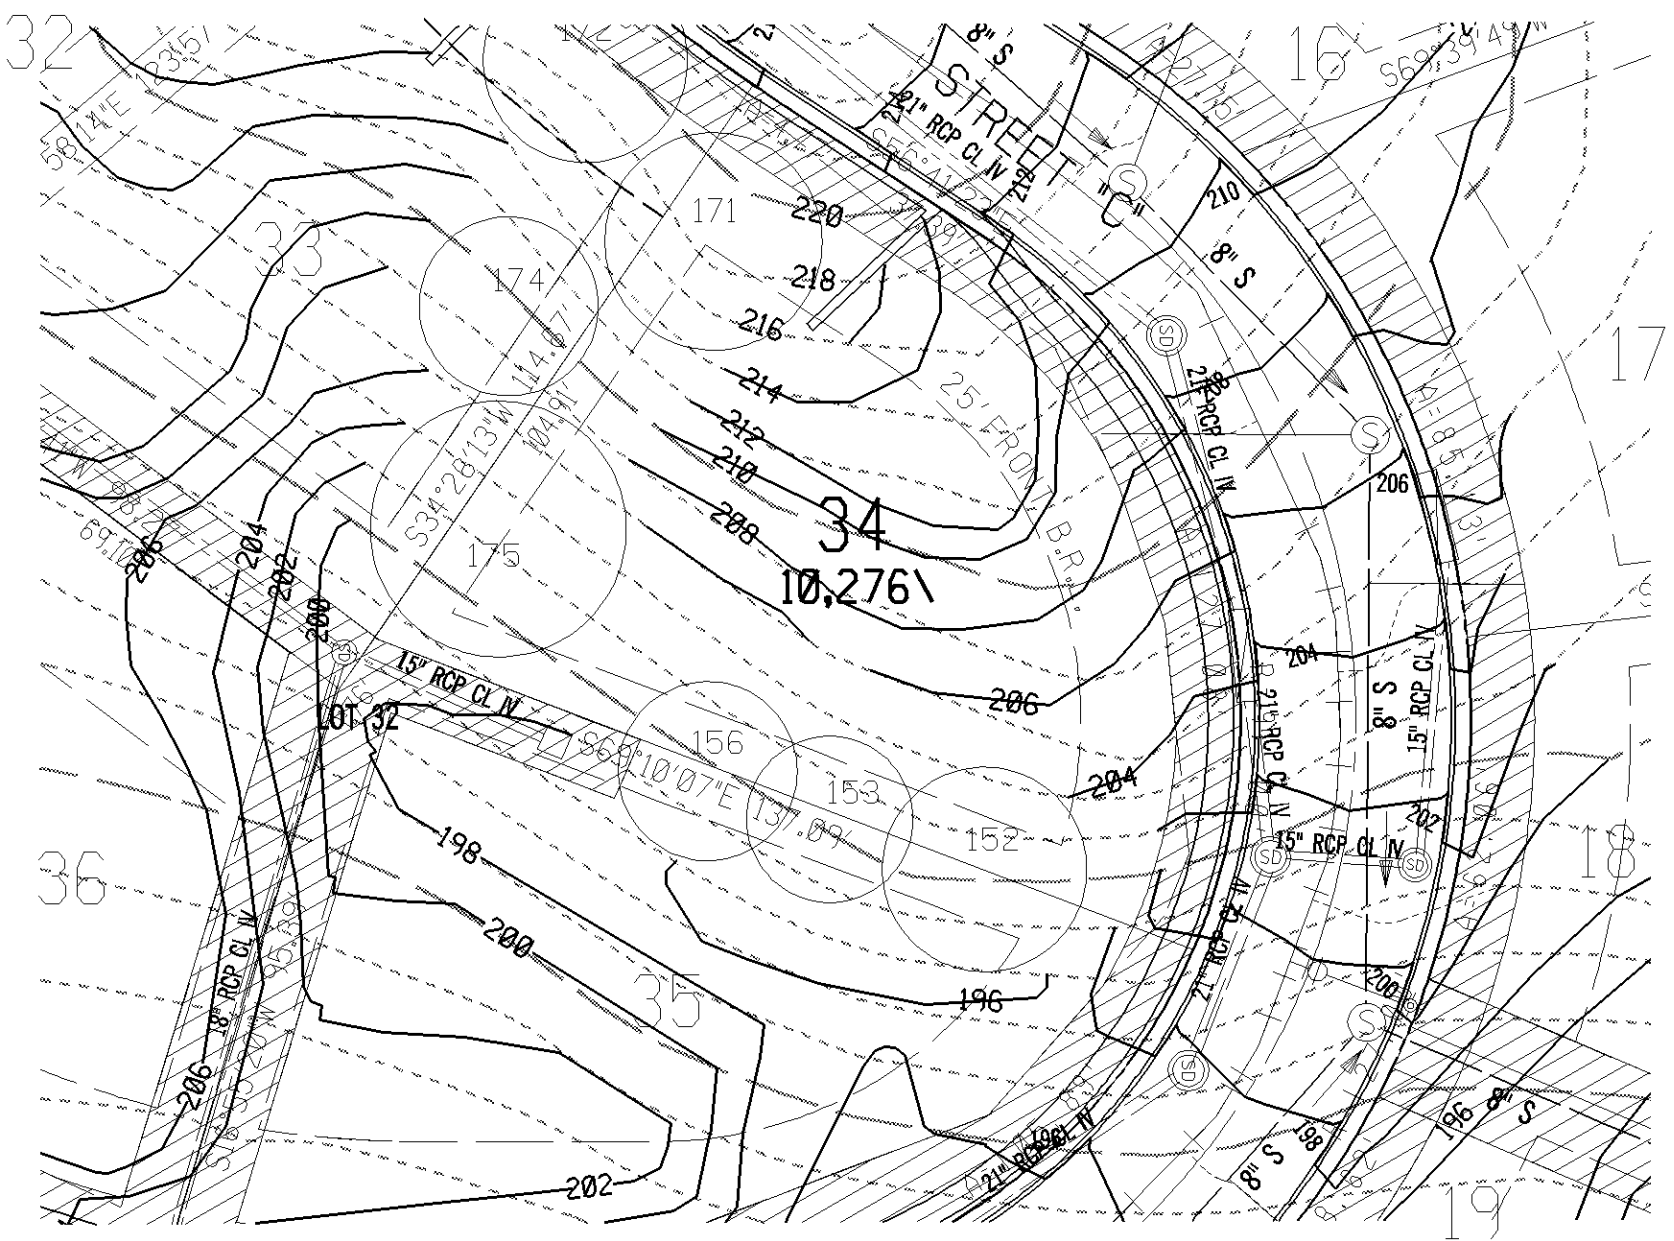

**GREENHORNE & O'MARA**  
 CONSULTING ENGINEERS  
 6110 PROST PLACE, LAUREL, MD 20707  
 PHONE: (301) 982-2800 FAX: (301) 223-2619  
 www.gand-o.com  
 FLORIDA GEORGIA MARYLAND NORTH CAROLINA PENNSYLVANIA VIRGINIA WEST VIRGINIA

GRADING AND UTILITY PLAN  
 PHILLIPS PARK  
**LOT 34**  
 LOT 800, SQUARE 1346  
 WARD 3  
 WASHINGTON, D.C.

DESIGN	SCALE	1" = 30'
DRAWN	3 OF 3	
CHECKED	SHEET	
6/30/06	2802	
DATE	PROJ. NO.	FILE NO.