


NORTH

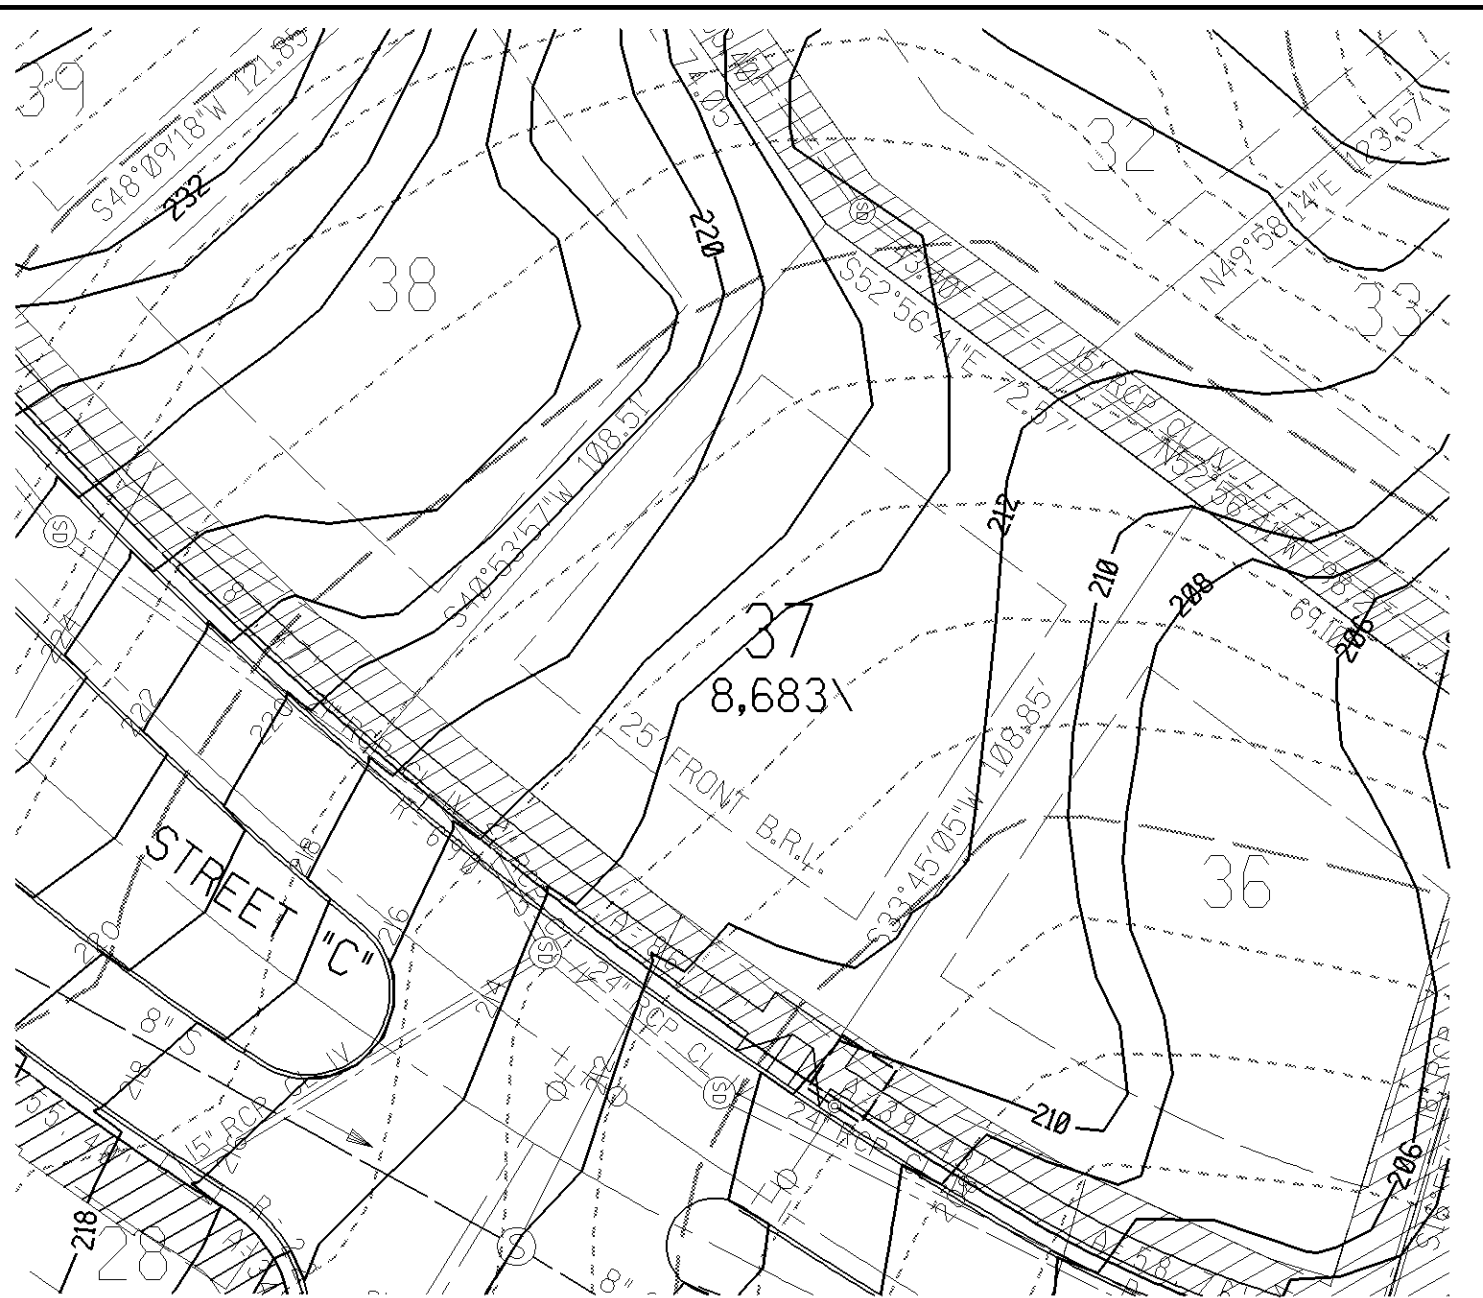

**GREENHORNE & O'MARA**  
CONSULTING ENGINEERS  
6110 FROST PLACE LAUREL, MD 20707  
PHONE: (301) 982-2800 FAX: (301) 220-2619  
WWW.G-AND-O.COM

FLORIDA GEORGIA MARYLAND NORTH CAROLINA PENNSYLVANIA VIRGINIA WEST VIRGINIA

GRADING AND UTILITY PLAN  
PHILLIPS PARK  
LOT 37  
LOT 800, SQUARE 1346  
WARD 3  
WASHINGTON, D.C.

DESIGN	SCALE	1" = 30'
DRAWN	3 OF 3	
CHECKED	SHEET	
DATE	PROJ. NO.	FILE NO.
6/30/06	2802	