


NORTH

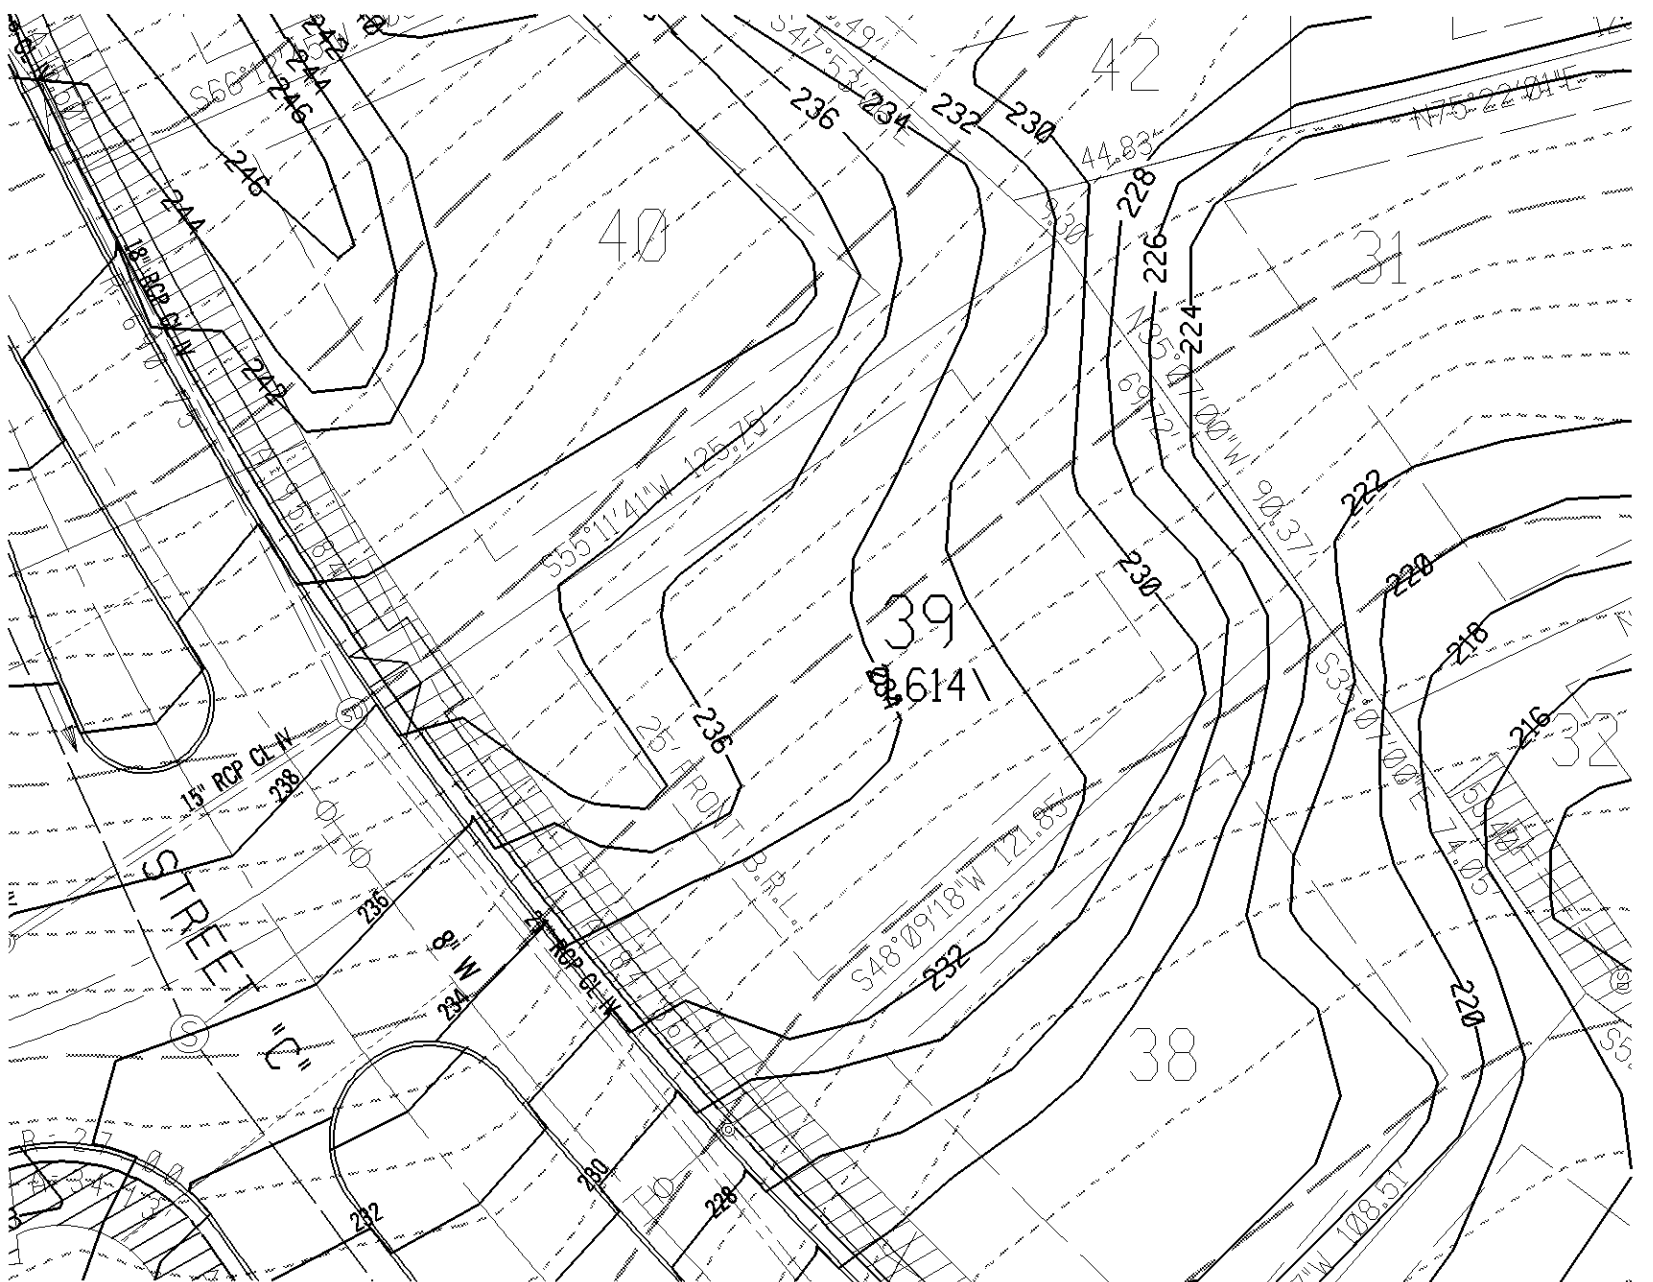

**GREENHORNE & O'MARA**

CONSULTING ENGINEERS

6110 FROST PLACE, LAUREL, MD 20707  
 PHONE: (301) 982-2800 FAX: (301) 223-2619  
 www.g-and-o.com

FLORIDA GEORGIA MARYLAND NORTH CAROLINA PENNSYLVANIA VIRGINIA WEST VIRGINIA

**GRADING AND UTILITY PLAN**

PHILLIPS PARK

**LOT 39**

LOT 800, SQUARE 1346  
 WARD 3  
 WASHINGTON, D.C.

DESIGN	SCALE	1" = 30'
DRAWN	3 OF 3	
CHECKED	SHEET	
6/30/06	2802	
DATE	PROJ. NO.	FILE NO.